


TECHNICAL DESCRIPTION

LINES	BEARINGS	DISTANCES	LINES	BEARINGS	DISTANCES	LINES	BEARINGS	DISTANCES
LOT 3325			LOT 3342			LOT 3977		
1-2	N 49° 25' E	142.93 M.	1-2	N 44° 03' W	24.08 M.	1-2	N 51° 15' E	39.43 M.
2-3	S 52° 07' E	20.39 M.	2-3	S 53° 03' W	23.62 M.	2-3	S 14° 51' E	30.97 M.
3-4	N 25° 13' E	17.28 M.	3-4	N 38° 33' W	24.22 M.	3-4	S 62° 43' W	12.34 M.
4-5	N 52° 05' E	14.47 M.	4-5	N 48° 03' E	63.41 M.	4-5	N 64° 28' W	18.82 M.
5-6	S 64° 28' E	18.82 M.	5-6	S 41° 24' E	45.37 M.	5-1	N 75° 20' W	11.10 M.
6-7	N 62° 43' E	12.34 M.	6-7	N 61° 49' E	25.62 M.			
7-8	S 37° 34' E	17.54 M.	7-8	S 29° 24' E	7.50 M.			
8-9	S 50° 38' W	46.11 M.	8-9	S 62° 45' W	24.60 M.			
9-10	S 37° 43' E	8.32 M.	9-1	S 51° 15' W	39.43 M.			
10-11	S 48° 59' W	152.18 M.						
11-1	N 37° 55' W	59.72 M.	LOT 3376					
LOT 3326			1-2	S 57° 53' W	15.88 M.			
1-2	N 53° 03' E	23.62 M.	2-3	S 59° 39' W	11.18 M.			
2-3	S 44° 03' E	24.08 M.	3-4	N 37° 34' W	17.54 M.			
3-4	S 75° 20' E	11.10 M.	4-5	N 53° 45' E	29.98 M.			
4-5	S 52° 15' W	14.47 M.	5-1	S 28° 43' E	20.00 M.			
5-6	S 25° 13' W	17.28 M.						
6-7	N 52° 07' W	20.39 M.						
7-1	N 32° 41' W	21.26 M.						

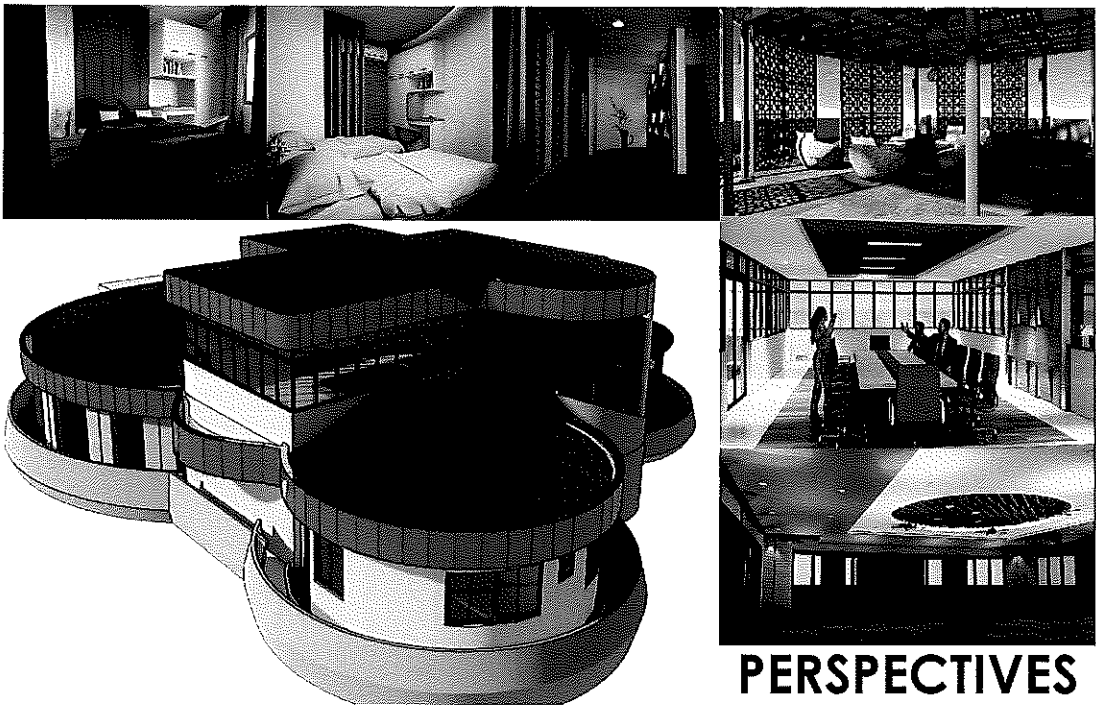

PERSPECTIVES

TABLE OF CONTENTS

ARCHITECTURAL	
CS	LOCATION/VICINITY MAP
	SITE DEVELOPMENT PLAN
	PERSPECTIVES
A1	ALPHABETIC OVERALL PLAN
A2	ALPHABETIC OVERALL PLAN
A3	ALPHABETIC OVERALL PLAN
A4	ALPHABETIC OVERALL PLAN
A5	ALPHABETIC OVERALL PLAN
A6	ALPHABETIC OVERALL PLAN
A7	ALPHABETIC OVERALL PLAN
A8	ALPHABETIC OVERALL PLAN
A9	ALPHABETIC OVERALL PLAN
A10	ALPHABETIC OVERALL PLAN
A11	ALPHABETIC OVERALL PLAN
A12	ALPHABETIC OVERALL PLAN
A13	ALPHABETIC OVERALL PLAN
A14	ALPHABETIC OVERALL PLAN
A15	ALPHABETIC OVERALL PLAN
A16	ALPHABETIC OVERALL PLAN
A17	ALPHABETIC OVERALL PLAN
STRUCTURAL	
S1	LOWER DECK FOUNDATION PLAN
	ROOF FRAMING PLAN
	COLUMN SCHEDULE AND DETAIL
S2	TRUSSES DETAIL, RAFTER & GIRT TRUSS
S3	UPPER DECK FOUNDATION PLAN
	ROOF FRAMING PLAN, CRYSTALL DETAIL
	OUTTER, ROOFING CONNECTION DETAIL
S4	STRUCTURAL CONSTRUCTION NOTES
PLUMBING	
P1	DRAINAGE PLAN, PLUMBING DETAIL
P2	PLUMBING PLAN, ROOFING PLAN
P3	ISOMETRIC, DETAILS, GENERAL NOTES
ELECTRICAL	
E1	LOWER & UPPER DECK LIGHTING LAYOUT
E2	LOWER & UPPER DECK POWER LAYOUT
E3	SINGLE LINE DIAGRAM, SCHEDULE OF LOADS
ELECTRONICS	
EE1	CCTV / LAN / TEL. & WIR. LAYOUT
EE2	FIRE DETECTION & ALARM SYSTEM PLAN
EE3	FDAS, CCTV, LAN/TEL/WIR. SINGLE DIAGRAM
MECHANICAL	
AC1	AIRCON & VENTILATION LAYOUT
AC2	HEAT LOAD ANALYSIS, GENERAL NOTES
FP1	LOWER & UPPER DECK FIRE PROTECTION PLAN

REPUBLIC OF THE PHILIPPINES
D P W H
OFFICE OF THE BUILDING OFFICIALS

ILOILO CITY

LAND USE & ZONING

LINE & GRADE

ARCHITECTURAL


STRUCTURAL

PLUMBING

ELECTRICAL

MECHANICAL


ELECTRONICS

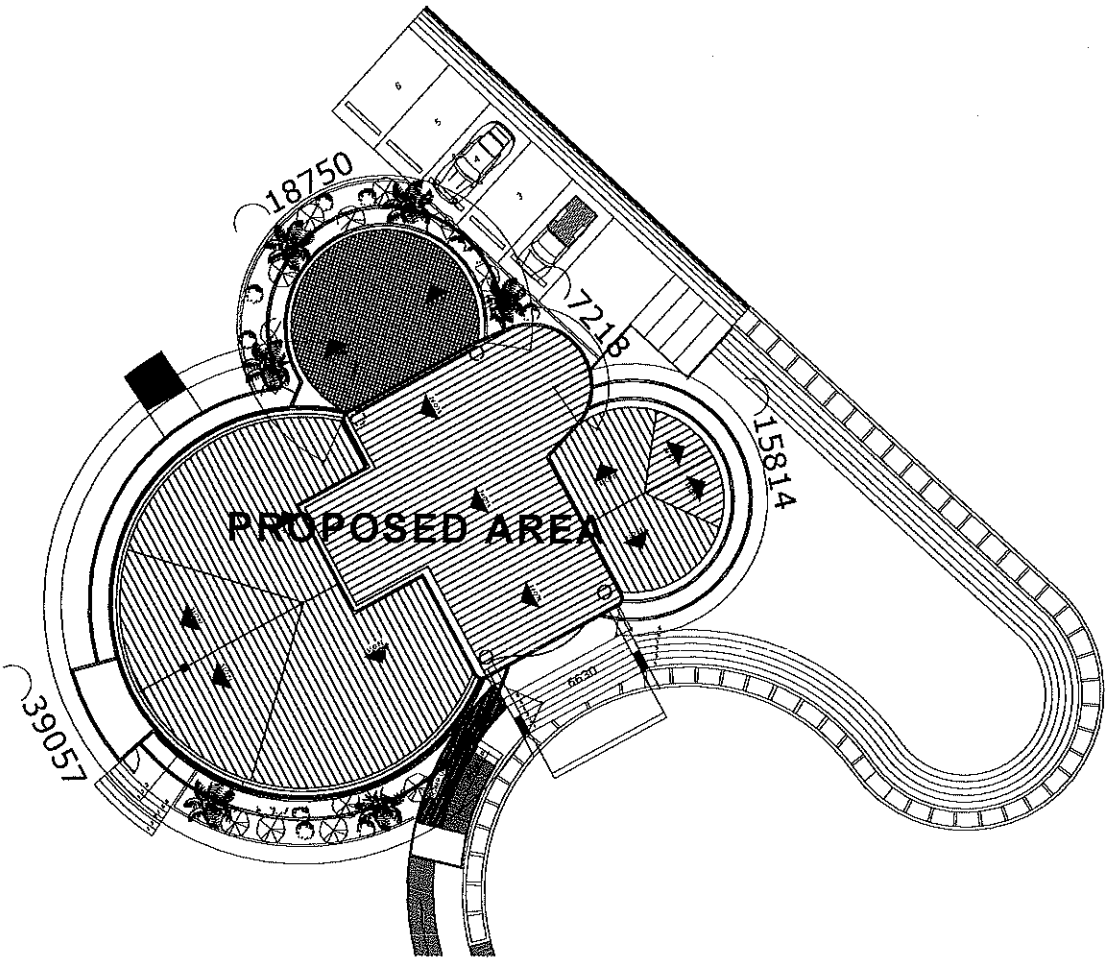

ILOILO SCIENCE AND TECHNOLOGY UNIVERSITY

SITE DEVELOPMENT PLAN

SCALE: AS SHOWN

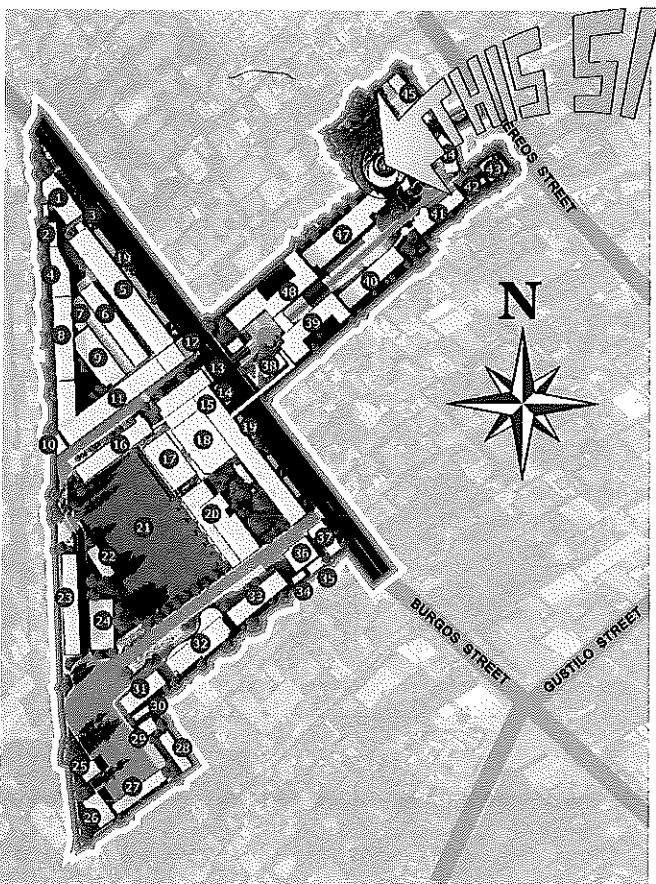

ILOILO SCIENCE AND TECHNOLOGY UNIVERSITY

LOCATION MAP

SCALE: AS SHOWN

TO JARO




TO LAPAZ

ILOILO SCIENCE AND TECHNOLOGY UNIVERSITY

VICINITY MAP


SCALE: AS SHOWN

DONE IN THE OFFICE OF:		DESIGN BY:	REQUESTED AND CONFORMED BY:	NOTE:	PROJECT TIME & LOCATION:	RECOMMENDING APPROVAL:	APPROVED BY:	SHEET CONTENTS:	SHEET NO.
ILOILO SCIENCE AND TECHNOLOGY UNIVERSITY		MARK JEROME SAMSON	DR. CARMELO C. AMBUT	ALL DESIGNS, DRAWINGS, SPECIFICATIONS AND COPIES PREPARED AND FORWARDED BY THE ARCHITECT BY CONNECTION WITH THE PROJECT ARE INSTRUMENTS OF PROFESSIONAL SERVICE. THEY ARE THE PROPERTY OF THE ARCHITECT. WHENEVER THEY ARE EXECUTED OR NOT, THEY ARE NOT TO BE REPRODUCED OR USED ON OTHER WORKS EXCEPT BY WRITTEN AGREEMENT WITH THE ARCHITECT.	CONSTRUCTION OF ISAT U I-HUB	DR. SAMMY A. DAITAO	DR. RUSS ALLEN B. NAPUD	AS SHOWN ABOVE	CS 1
PLANNING DEVELOPMENT & AUXILIARY SERVICES		PROJECT OFFICER	VICE PRESIDENT FOR RESEARCH		RESEARCH HUB ROOFDECK, ISAT U ILOILO CITY CAMPUS, BURGOS ST., LA PAZ, ILOILO CITY	DIRECTOR, PDAS	VP FOR ADMINISTRATION	DATE START:	1
BURGOS ST., LA PAZ, ILOILO CITY		PER NO.: 46214						DATE FINISH:	
		ISSUED ON:						REV. NO.:	
		ISSUED AT: ILOILO CITY							

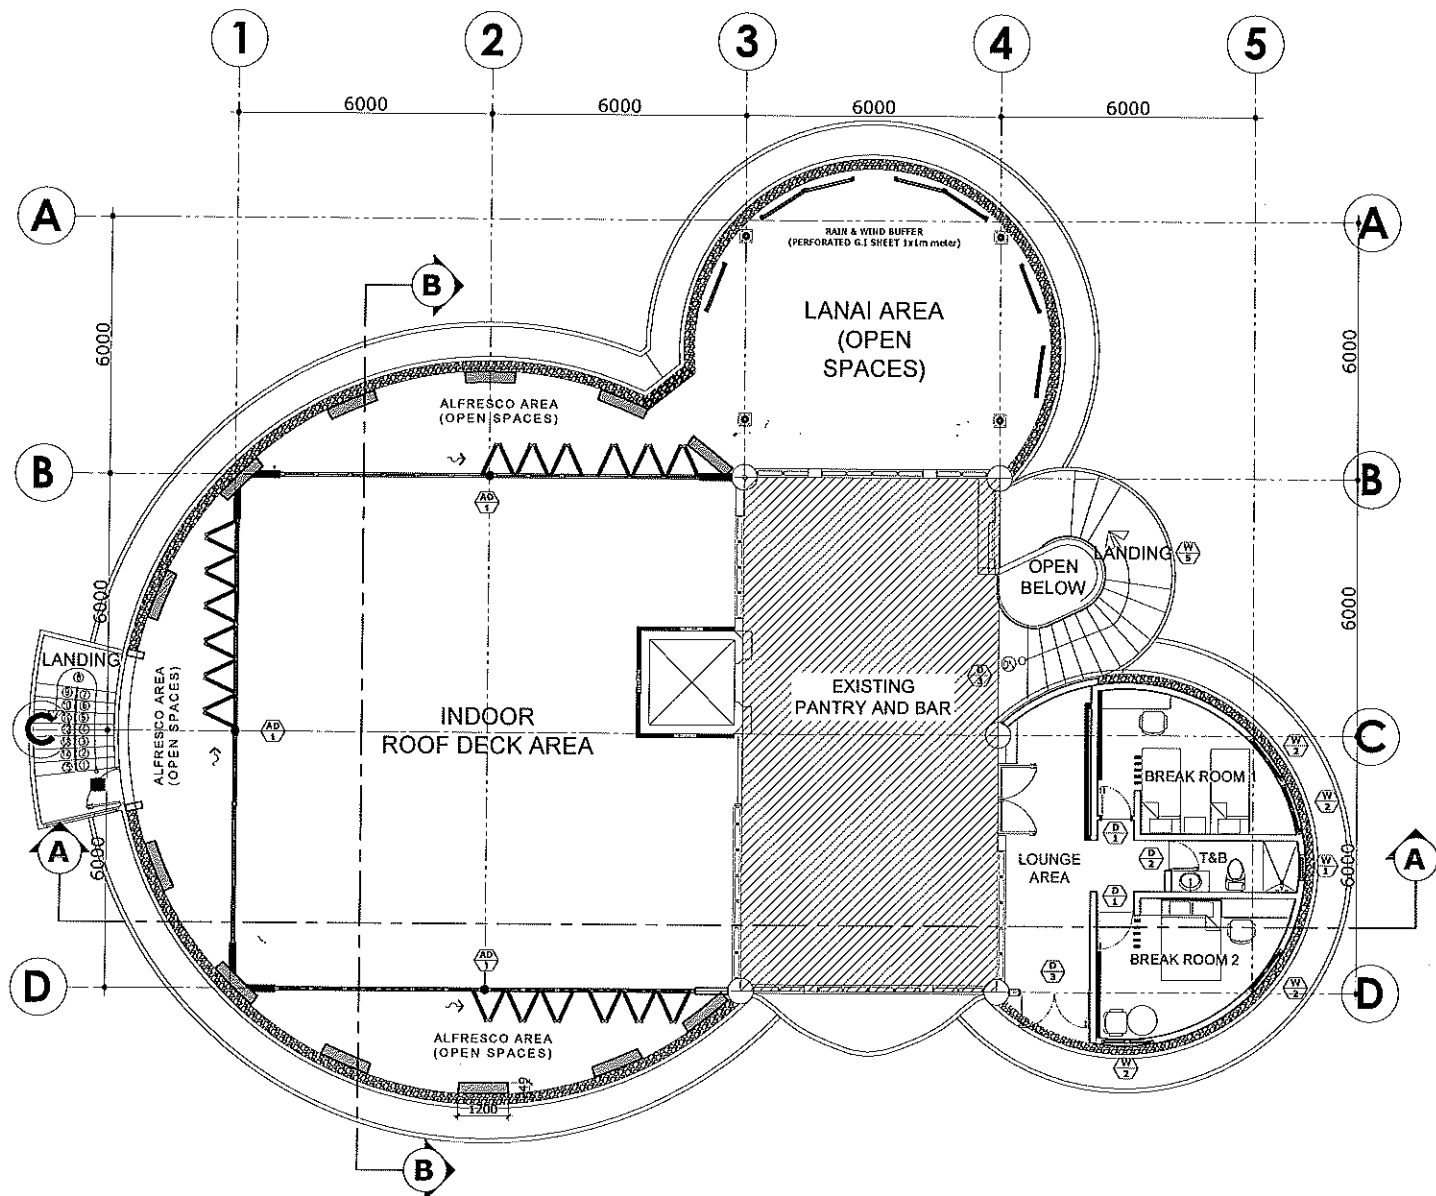

RESEARCH HUB LOWER DECK
ALFRESCO FLOOR PLAN

SCALE: 1:100MTS

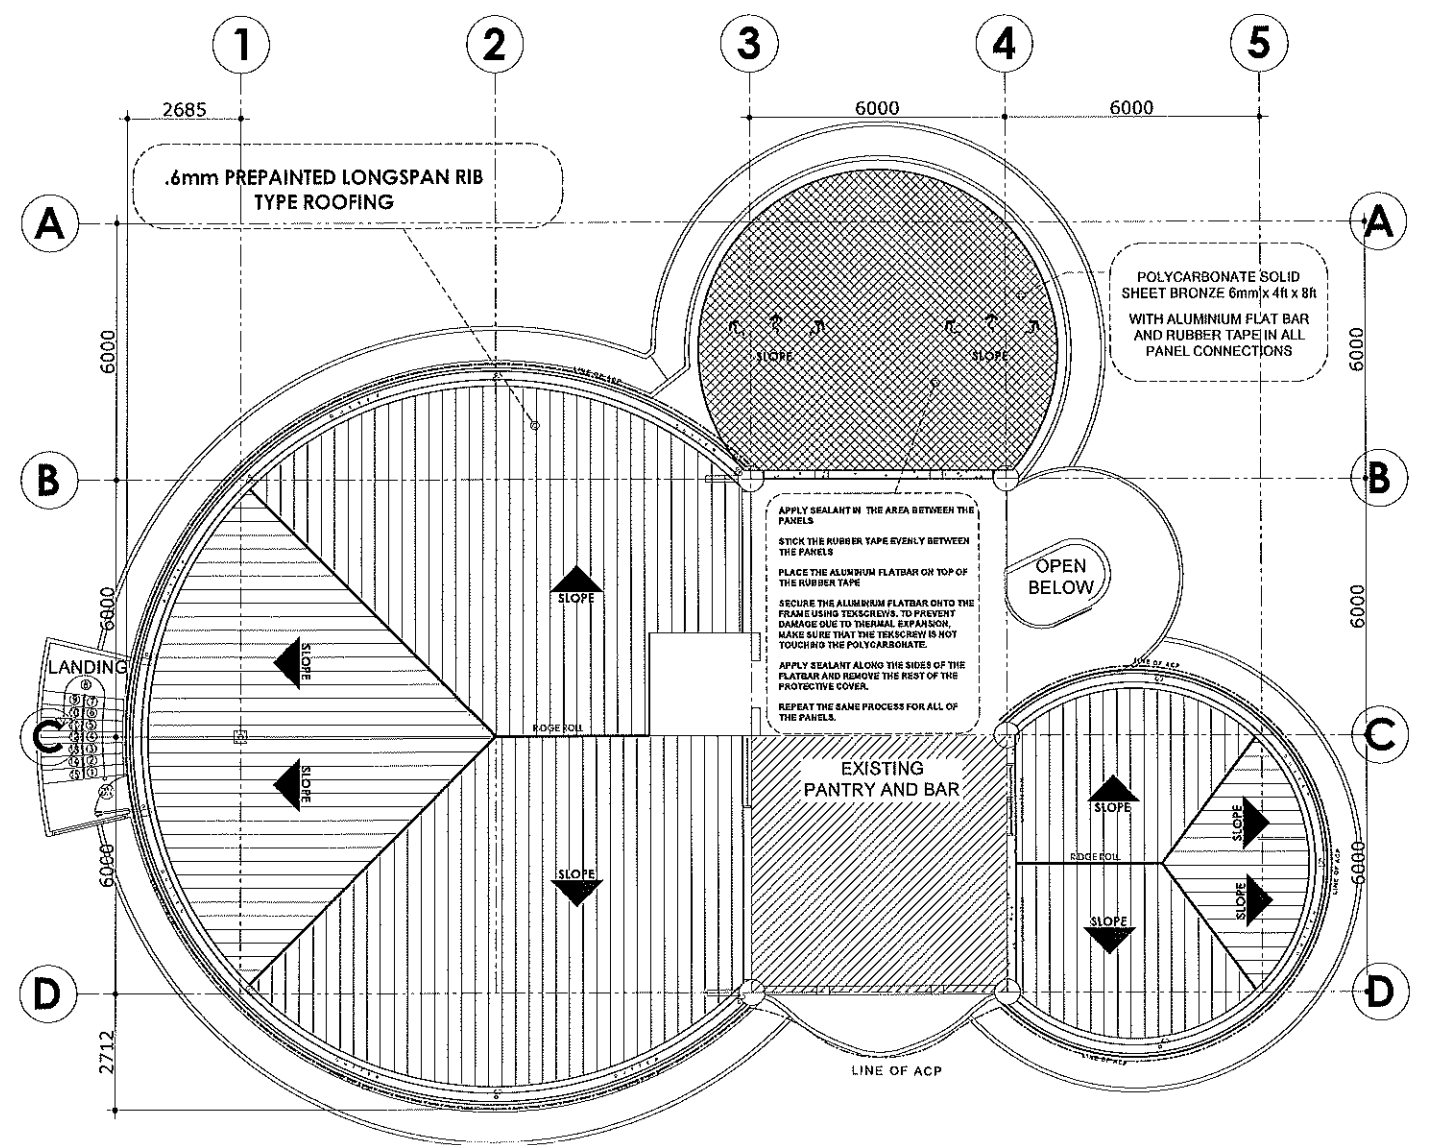

RESEARCH HUB LOWER DECK
ROOFING PLAN



SCALE: 1:100MTS

DONE IN THE OFFICE OF: ILOILO SCIENCE AND TECHNOLOGY UNIVERSITY PLANNING DEVELOPMENT & AUXILIARY SERVICES BURGOS ST., LA PAZ, ILOILO CITY	DESIGN BY: <i>Mark Jerome Samson</i> MARK JEROME SAMSON PROJECT DEVELOPMENT OFFICER PIR NO.: VRC-NO.: 46214 ISSUED ON: FEB 729-795-514 ISSUED AT: ILOILO CITY IAPCA TIO.	REQUESTED AND CONFORMED BY: <i>Dr. Carmelo C. Ambut</i> DR. CARMELO C. AMBUT VICE PRESIDENT FOR RESEARCH	NOTE ALL DESIGNS, DRAWING, SPECIFICATIONS AND COPIES PREPARED AND FURNISHED BY THE ARCHITECT IN CONNECTION WITH THE PROJECT ARE INSTRUMENTS OF PROFESSIONAL SERVICE, THEY ARE THE PROPERTY OF THE ARCHITECT, WHETHER THEY ARE EXECUTED OR NOT, THEY ARE NOT TO BE REPRODUCED OR USED ON OTHER WORK EXCEPT IF WRITTEN AGREEMENT WITH THE ARCHITECT. RA 9266, ART 4, SEC 33	PROJECT TITLE & LOCATION: CONSTRUCTION OF ISAT U I-HUB RESEARCH HUB ROOFDECK, ISAT U ILOILO CITY CAMPUS, BURGOS ST., LA PAZ, ILOILO CITY	RECOMMENDING APPROVAL: <i>Dr. Sammy A. Daitao</i> DR. SAMMY A. DAITAO DIRECTOR, PDAS	APPROVED BY: <i>Dr. Russ Allen B. Napud</i> DR. RUSS ALLEN B. NAPUD VP FOR ADMIN AND FINANCE	APPROVED BY: <i>Dr. Gabriel M. Salistre, Jr.</i> DR. GABRIEL M. SALISTRE, JR. SUC PRESIDENT	SHEET CONTENTS: AS SHOWN ABOVE DRAWN BY: DATE START: DATE FINISH: REV. NO.:	SHEET NO. A 1 18
--	--	---	--	---	---	---	--	--	------------------------------------



STAINLESS ROUND TUBE
ESCUTCHEON/FLANGE (FLOOR
MOUNTED FOR BALUSTERS)
(RETOUCHING, REPLASTERING, AND
REPAINTING THE DAMAGED
WALL/FLOOR OF THE ANCHORED
RAILING.)

STAINLESS HANDRAIL BRACKET
(WALL MOUNTED)
VERIFY ACTUAL THE LOCATION OF
STAINLESS BRACKET FOR
STABILITY OF THE RAILINGS.

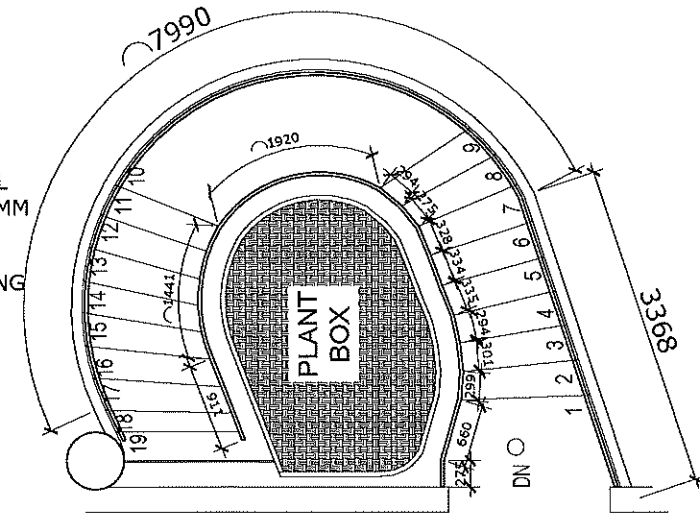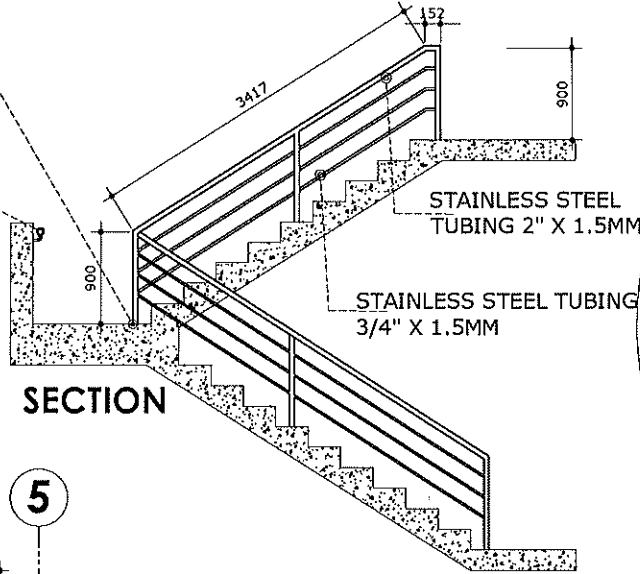


REPUBLIC OF THE PHILIPPINES
D P W H
OFFICE OF THE BUILDING OFFICIALS

ILOILO CITY

LAND USE & ZONING




STAINLESS ROUND TUBE
ESCUTCHEON

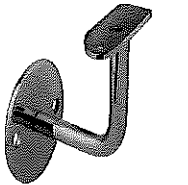

STAINLESS HANDRAIL BRACKET


STAIR RAILING ROOF DECK

SCALE: 1:200MTS

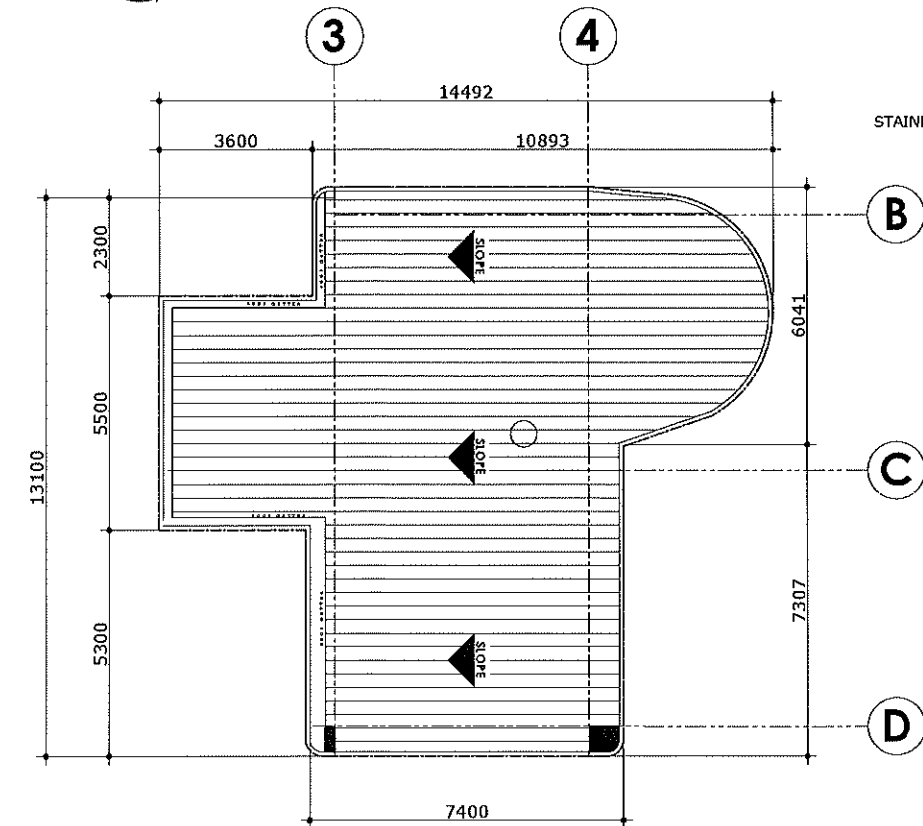

RESEARCH HUB UPPER DECK MULTIPURPOSE ROOFING PLAN

SCALE: 1:100MTS

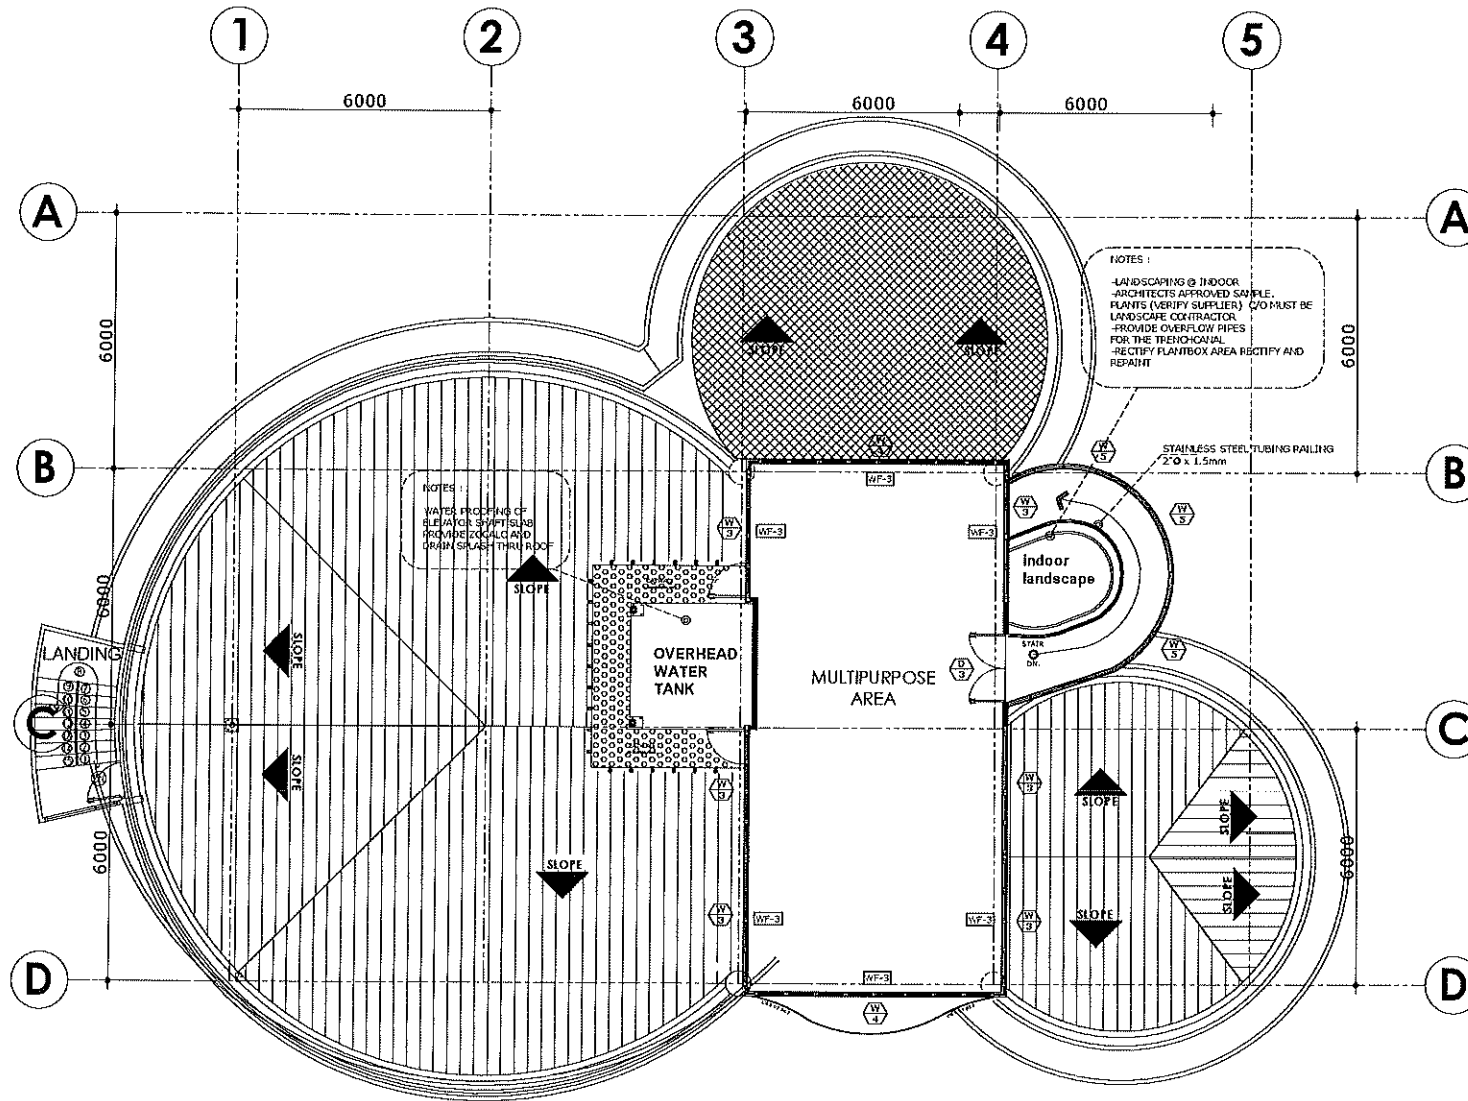

RESEARCH HUB UPPER DECK MULTIPURPOSE AREA FLOORPLAN

SCALE: 1:100MTS

DONE IN THE OFFICE OF:	DESIGNED BY:	REQUESTED AND CONFIRMED BY:	NOTE:	PROJECT TITLE & LOCATION:	RECOMMENDING APPROVAL:	APPROVED BY:	SHEET CONTENTS:	SHEET NO.
ILOILO SCIENCE AND TECHNOLOGY UNIVERSITY PLANNING DEVELOPMENT & AUXILIARY SERVICES BURGOS ST., LA PAZ, ILOILO CITY	MARK JEROME SAMSON PROJECT DEVELOPMENT OFFICER I PTR NO.: 46214 ISSUED ON: 729-795-514 ISSUED AT: ILOILO CITY	DR. CARMELO C. AMBUT VICE PRESIDENT FOR RESEARCH	ALL DESIGNS, DRAWINGS, SPECIFICATIONS AND COPIES PREPARED AND FURNISHED BY THE ARCHITECT IN CONNECTION WITH THE PROJECT ARE INSTRUMENTS OF PROFESSIONAL SERVICE, THEY ARE THE PROPERTY OF THE ARCHITECT, WHETHER THEY ARE EXECUTED OR NOT, THEY ARE NOT TO BE REPRODUCED OR USED ON OTHER WORK EXCEPT BY WRITTEN AGREEMENT WITH THE ARCHITECT. RA 9266, ART 4, SEC 33	CONSTRUCTION OF ISAT U I-HUB RESEARCH HUB ROOFDECK, ISAT U ILOILO CITY CAMPUS, BURGOS ST., LA PAZ, ILOILO CITY	DR. SAMMY A. DAITAO DIRECTOR, PDAS	DR. RUSS ALLEN B. NAPUD VP FOR ADMIN AND FINANCE DR. GABRIEL M. SALUSTRE, JR. SUC PRESIDENT III	AS SHOWN ABOVE DRAWN BY: DATE START: DATE FINISH: REV. NO.:	A 2 18